


LAST SAVED BY: kparikh 19/5/25 8:49 AM

PLOTTED BY: Khyati M. Parikh


This drawing is property of Mamta Shah & Associates. Without our prior consent, it must be neither copied nor made available to third parties, nor must it be used by the recipient or third parties for the purpose other than for which it is meant.

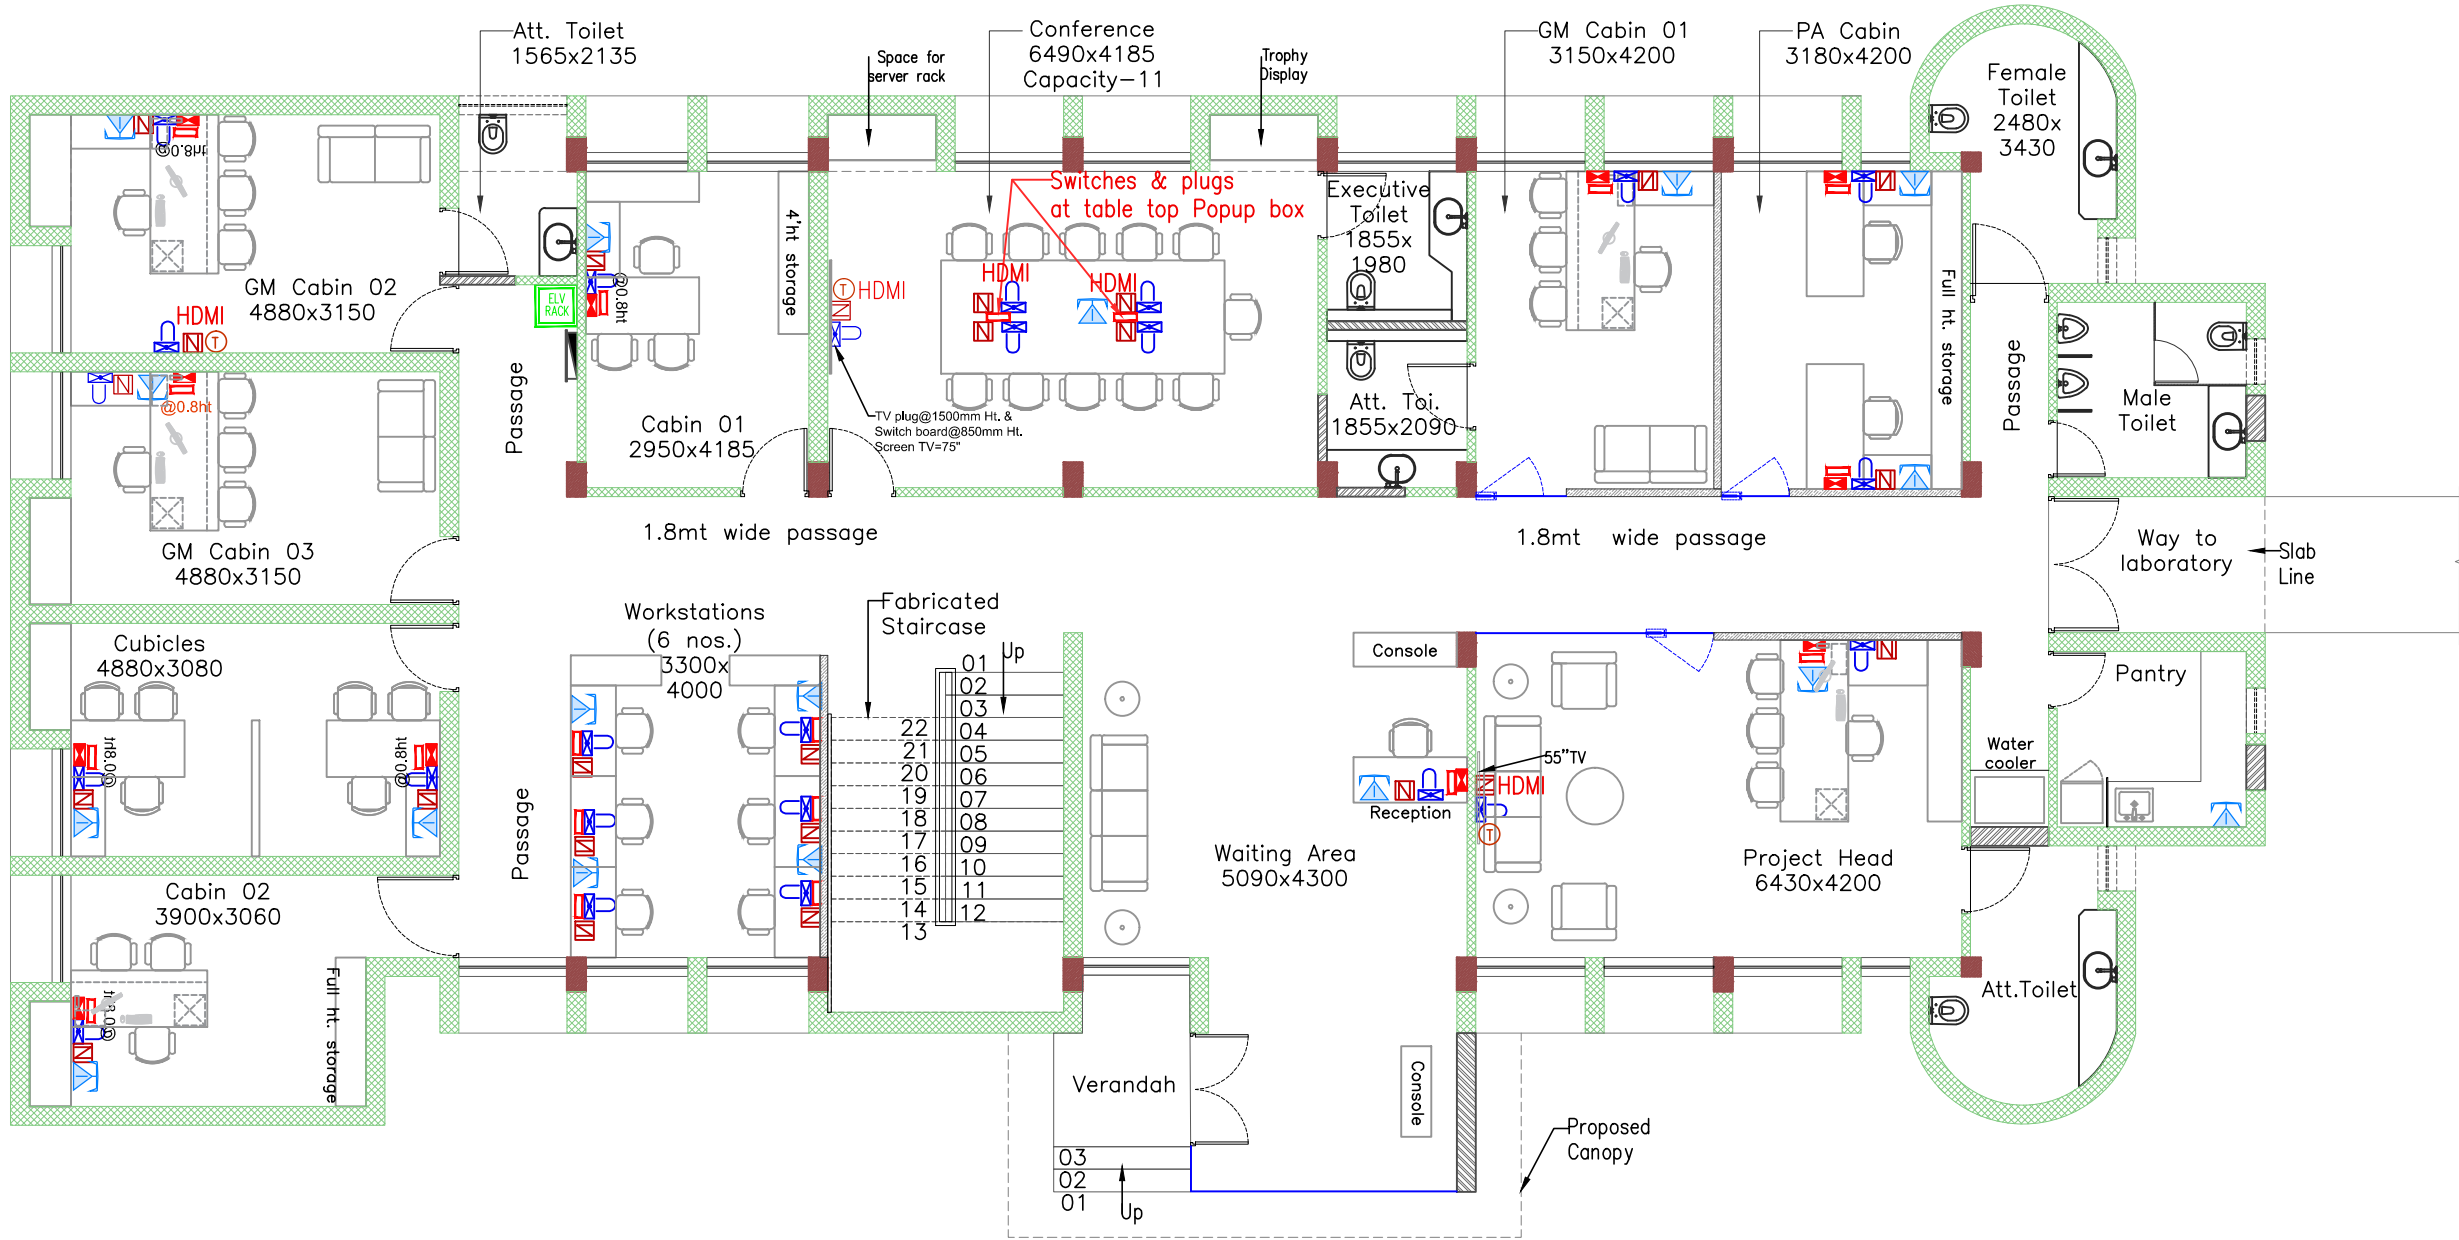

General Notes :

Legends for hatch	
	Existing Brick wall masonry
	Existing RCC Structure
	Existing Wood+Glass partition
	Open Courtyard land area

R4	19-05-25	Softcopy	GMDC		Tender	KAP
R3	22-02-25	Softcopy	GMDC		Tender	KAP
R2	01-03-24	Softcopy	GMDC		Tender	KAP
R1	27-09-23	Softcopy	GMDC		Tender	KAP
R0	11-07-23	Softcopy	GMDC		Tender	KAP
Rev	Date	Issued	Issued to		Issued for	Author

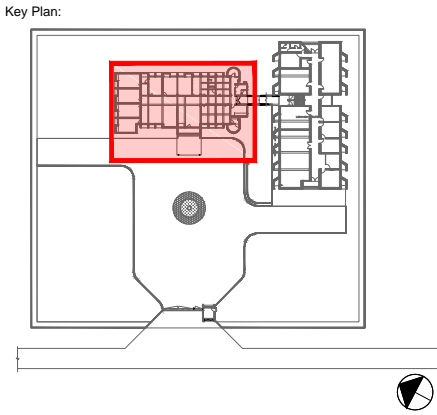

Project: GMDC Township Development

Drawing: Telecommunication Layout  
Office Building\_Ground Floor  
Sheet 01

Drawing Code: 2310\_INT\_TD\_OFC\_TEL\_R4

Print Size: A3 Scale: 1:100

File Title: 2310\_INT\_TD\_OFC\_TEL\_R4

Project Code: MSA 2310	Project Type: Arc & Int	Location: Ambaji
Print Date: 19-May-25	Drawn By: K Parikh	Checked By: K Patel
		Approved By: M Shah

**MAMTA SHAH & ASSOCIATES**  
Architects & Interior Designers  
C-12, Chanakyapuri Society,  
Chanakyapuri Char Rasta,  
New Sana Road, Baroda  
Ph. No. +91 985 2712267 / 2710967  
mamta@msain.com / www.msain.com

Client: **Gujarat Mineral Development corporation**



Note:-  
For all the cabins Switchboard on the table top(Flipup Box).

Note :- Cabin

- A) Below mentioned points has been executed at Cabin Table top with Flip up Box:-
1. Computer Network point
  2. 2 nos 5 Amp Power Supply Points (UPS)
  3. Telephone Point (1 Nos.)
  4. 1 nos 5 & 15 Amp Power Supply points

- B)Below mentioned points has been executed at Table top Wall Switch Board:-
1. Raw power 5 amp plug point with switch.
  2. Call bell point(Only GM & Head Cabin)

Note :- Workstation

- Below mentioned points has been executed at Cabin Table top with Flip up Box:-
1. Computer Network point
  2. 2 nos 5 Amp Power Supply Points (UPS)
  3. Telephone Point (1 Nos.)
  4. 1 nos 5 & 15 Amp Power Supply points

TC Legend	
Symbol	Description
	Intercom Telephone
	Distribution board (T.P.)
	Rack

Legend for Electrical

Symbol	Wall mounted lighting
	UPS Power Supply 2 nos.- 6 amp plug for (PC & Monitor)
	Network for Server
	Switch board bottom @ mentioned heights
	5 - AMP Plug point
	15 - AMP Plug point
	TV Cable
	Call Bell Switch
	Flip up box For table top

